




THIRD FLOOR PLAN
SCALE 1/8" = 1'-0"

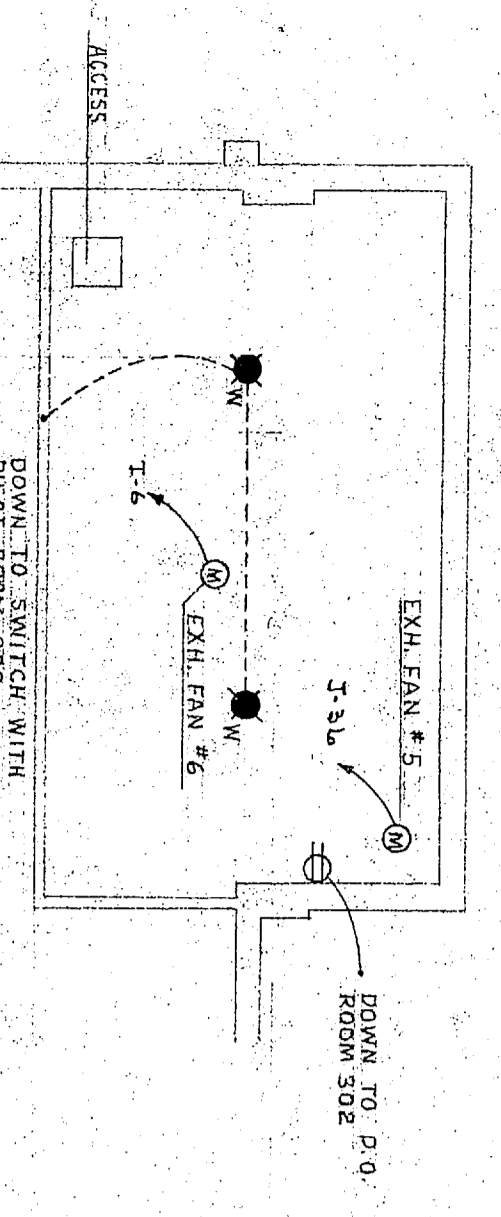


FURRED SPACE PLAN
SCALE 1/8" = 1'-0"

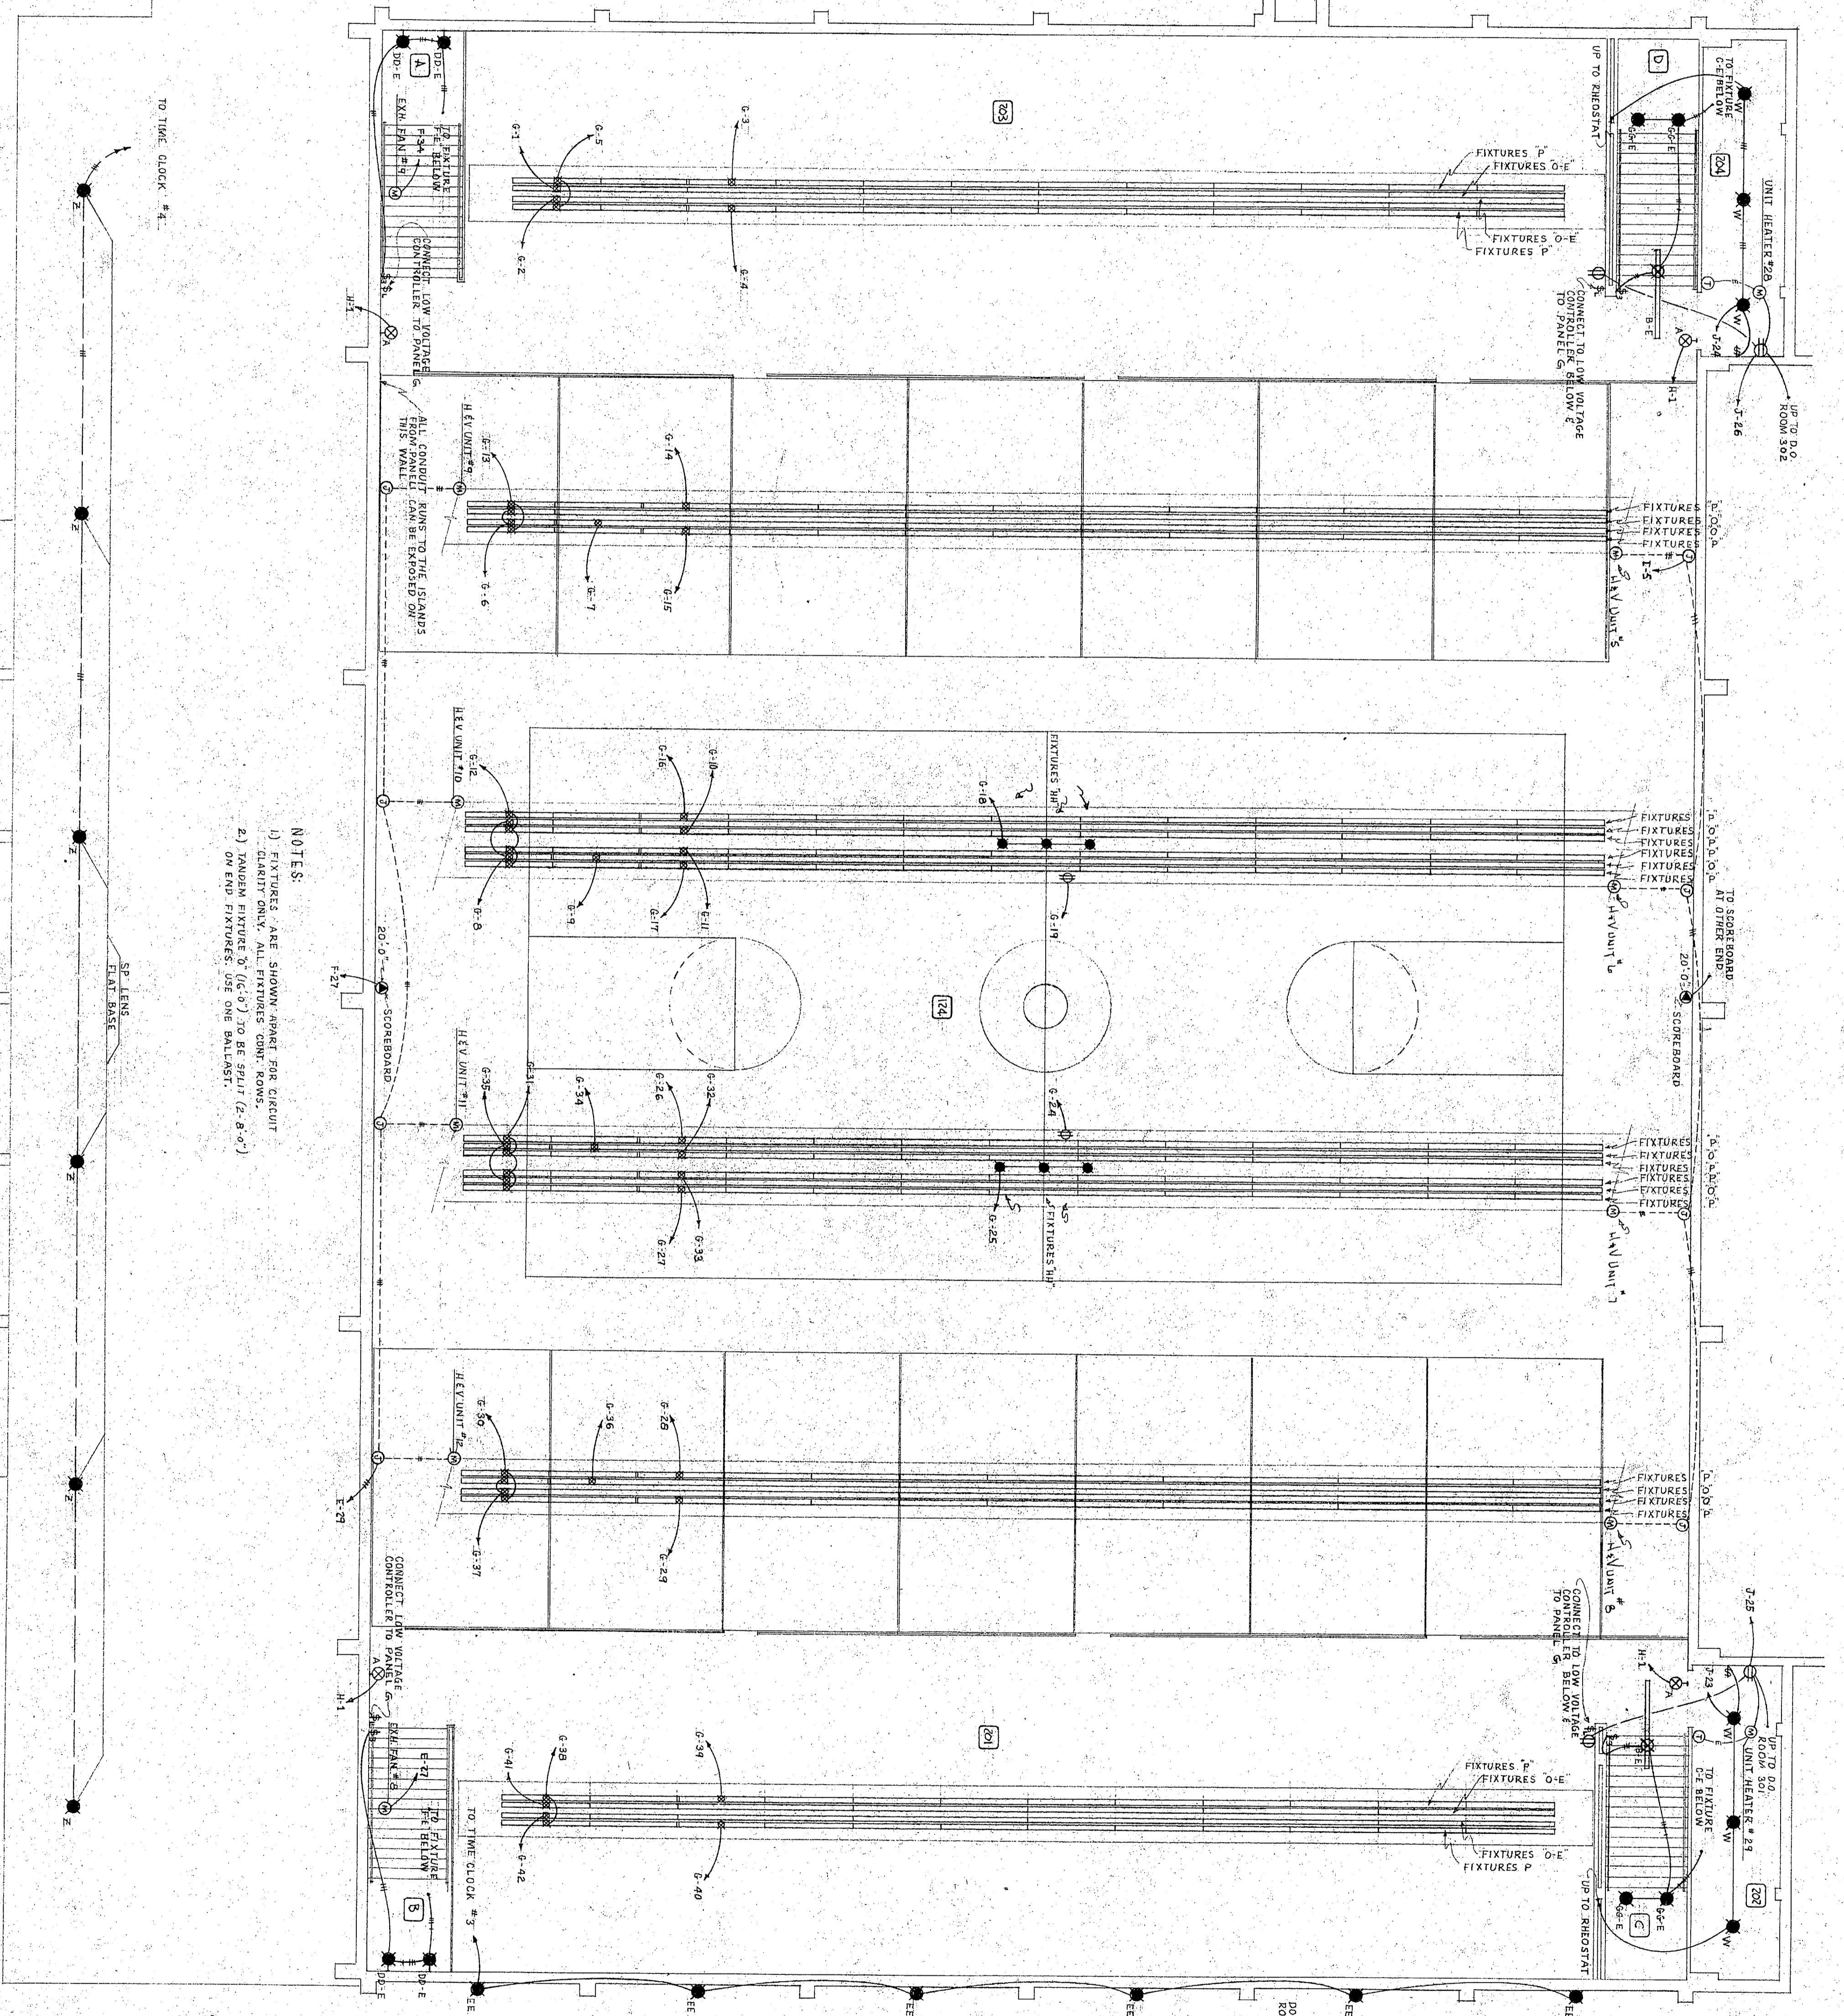

NOTES:
 1.) FIXTURES ARE SHOWN AWAY FOR CIRCUIT CLARITY ONLY. ALL FIXTURES CONT. ROWS.
 2.) RANDOM FIXTURES (G.C.S.) TO BE SPIT (2'-8" O.C.) ON END FIXTURES USE ONE BALLAST.

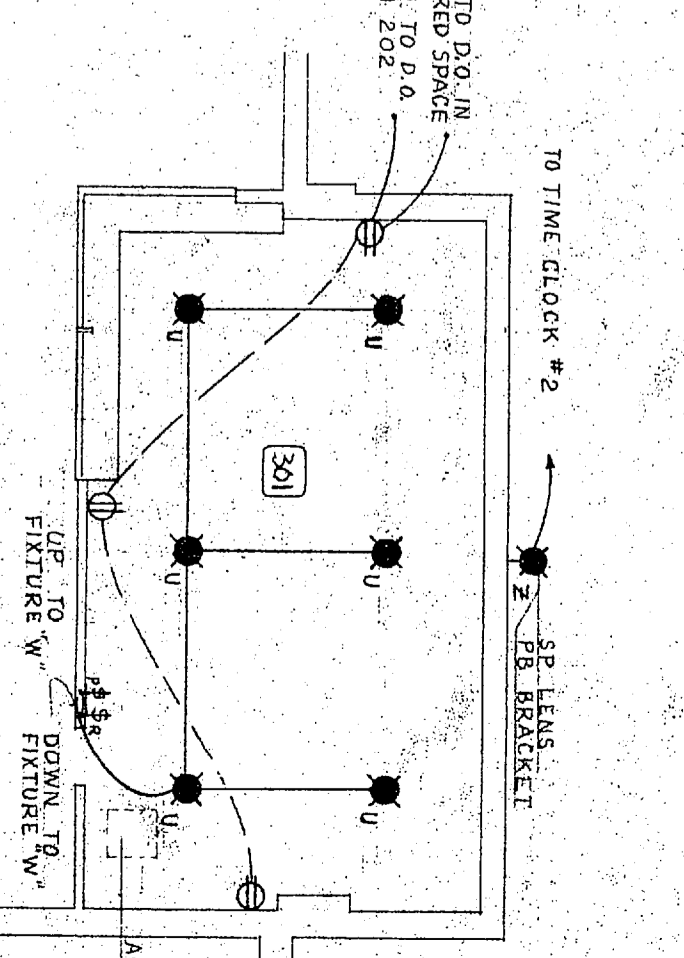

THIRD FLOOR PLAN
SCALE 1/8" = 1'-0"

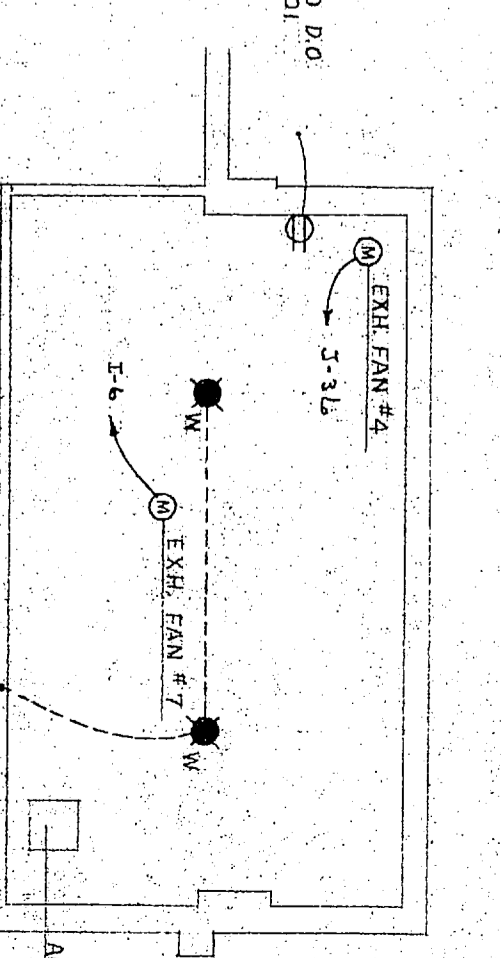

FURRED SPACE PLAN
SCALE 1/8" = 1'-0"

SECOND FLOOR PLAN ELECTRICAL
SCALE 1/8" = 1'-0"

CONSULTANTS
 DRAPER ENGINEERING BUILDINGS, MONTANA
 1015 N. CENTER ST. SPOKANE, MONTANA 59102
 (509) 325-1111
 FAX (509) 325-1112
 WWW.DRAPERENGINEERING.COM

DESIGNED BY
 JOHN A. CASHING
 CHECKED BY
 JEFFREY L. TERRELL

DATE 11-2-00

DRAPER ENGINEERING BUILDINGS, MONTANA
 1015 N. CENTER ST. SPOKANE, MONTANA 59102
 (509) 325-1111
 FAX (509) 325-1112
 WWW.DRAPERENGINEERING.COM

DESIGNED BY
 JOHN A. CASHING
 CHECKED BY
 JEFFREY L. TERRELL

DATE 11-2-00

CASHING, TERRELL and ASSOCIATED ARCHITECTS
 BILINGS, MONTANA