




SOUND SYSTEM RISER DIAGRAM NOT TO SCALE

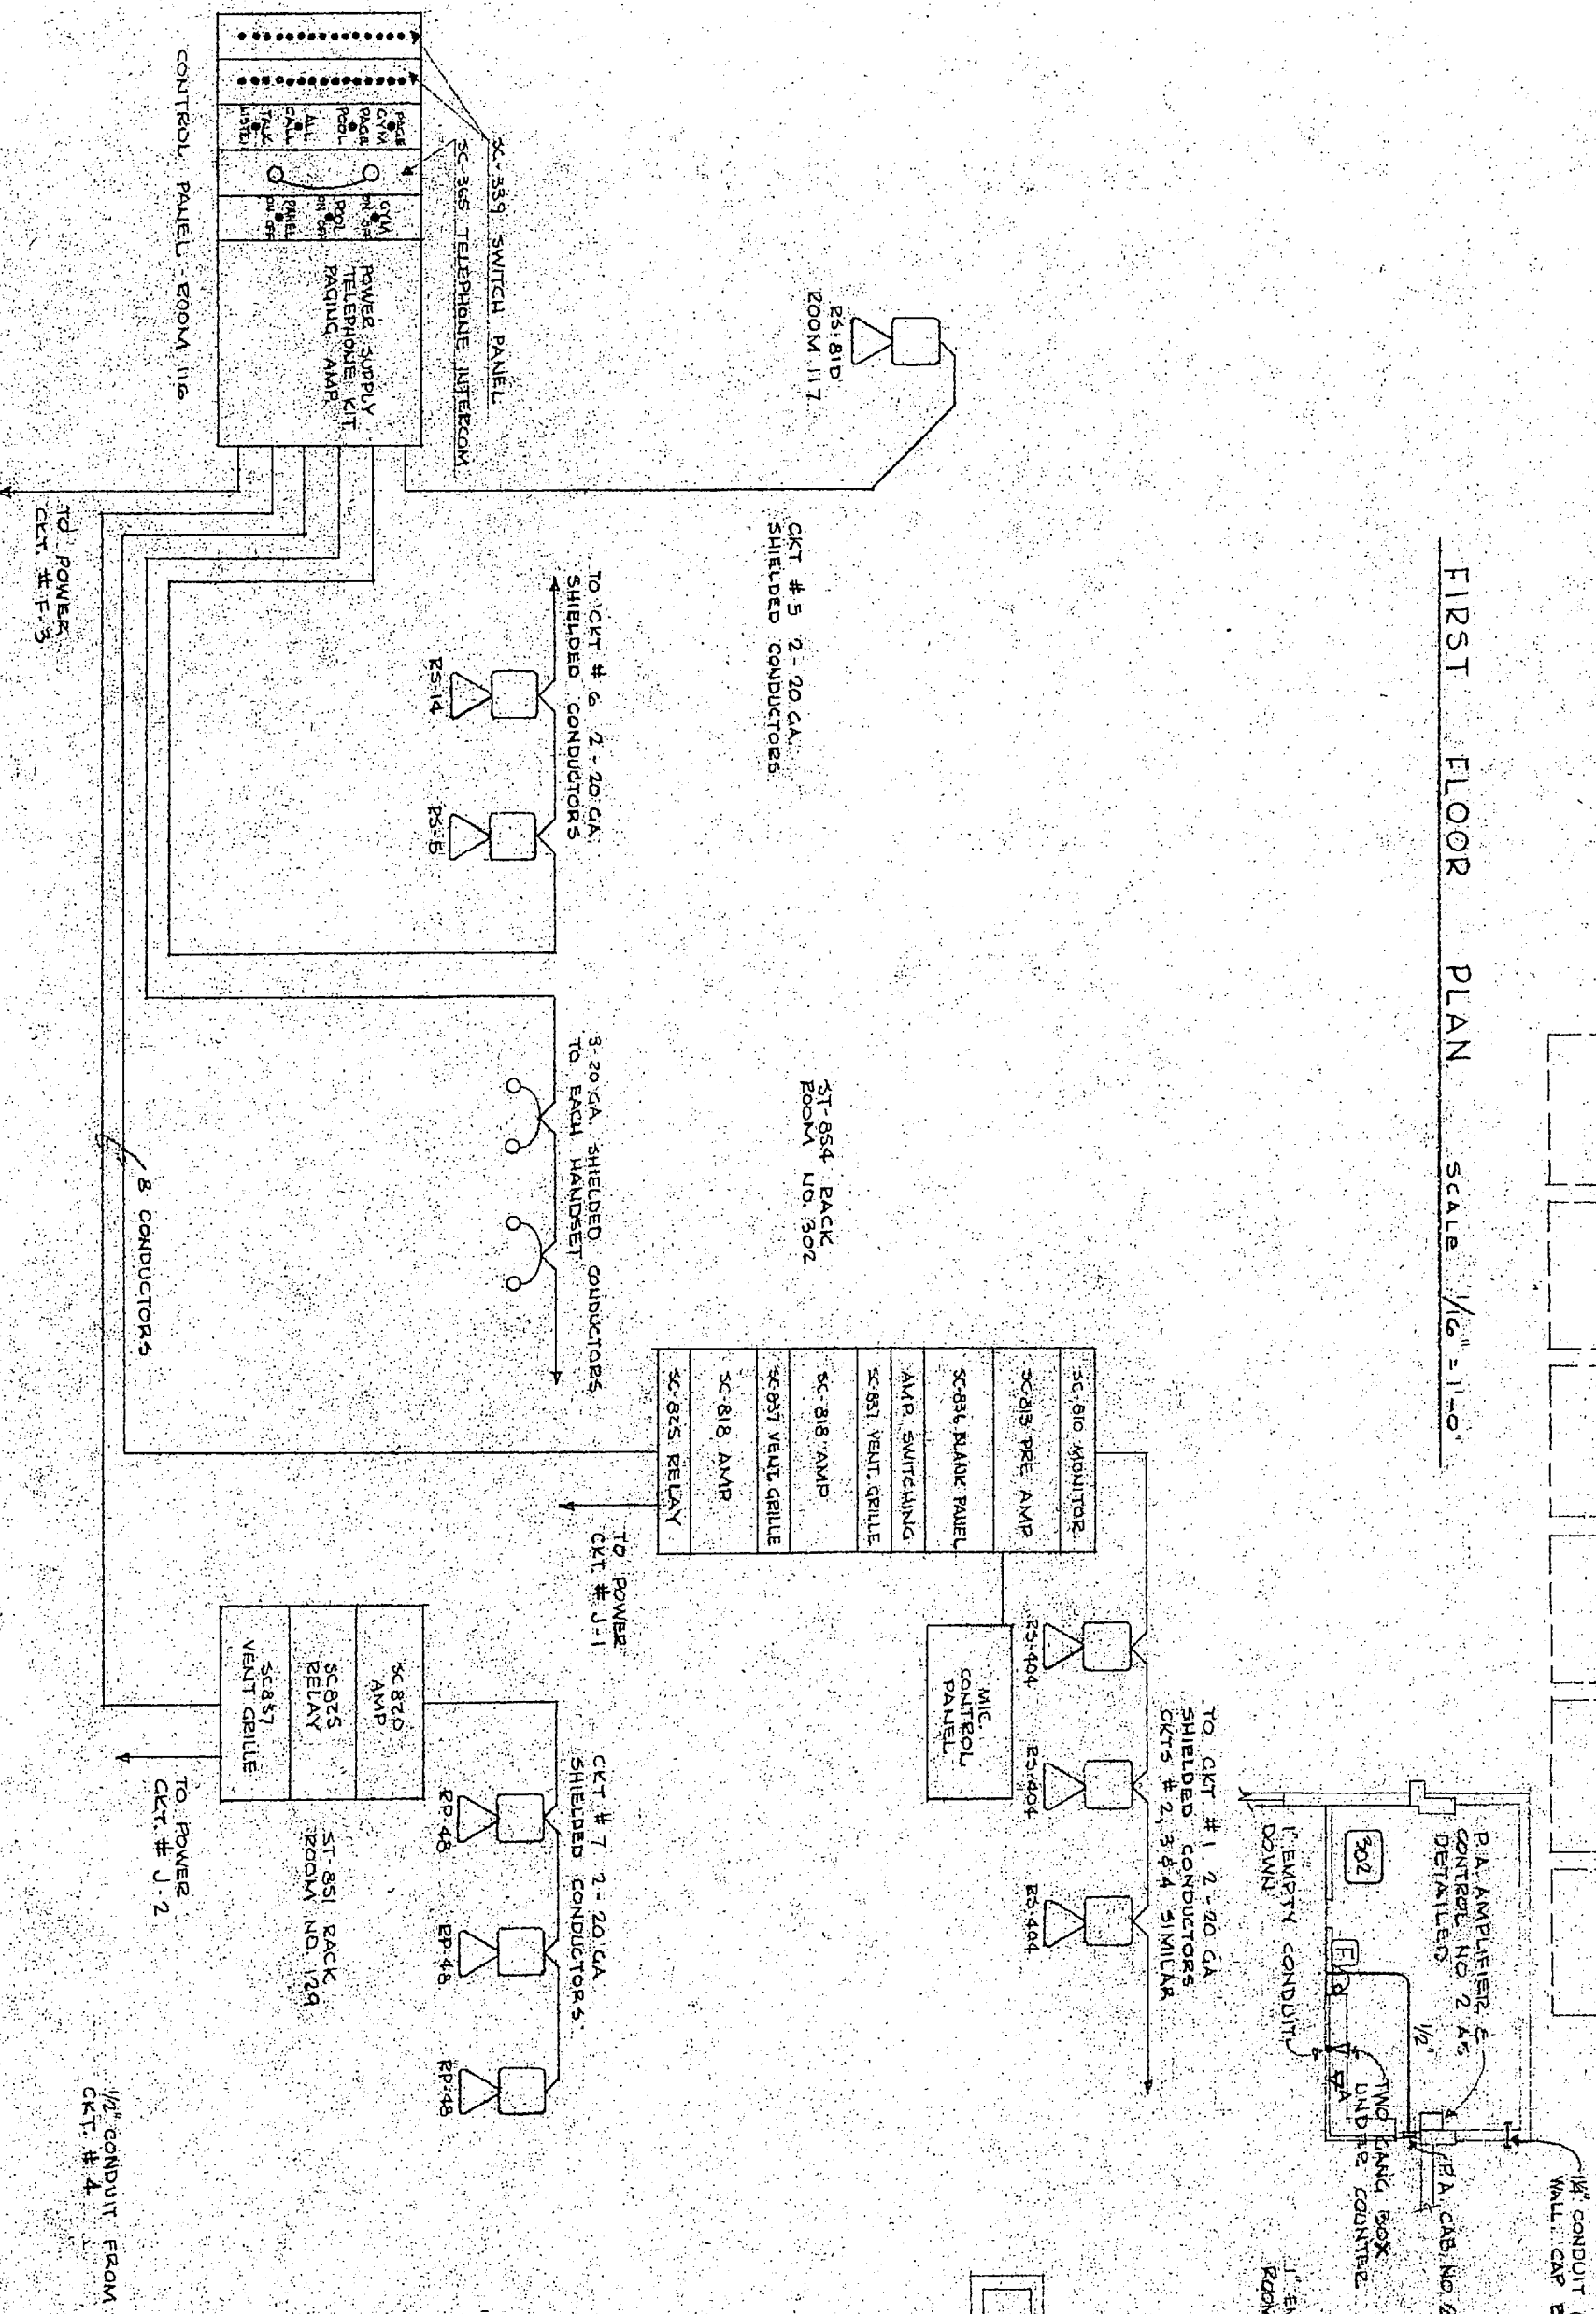


FIRST FLOOR PLAN SCALE 1/8" = 1'-0"

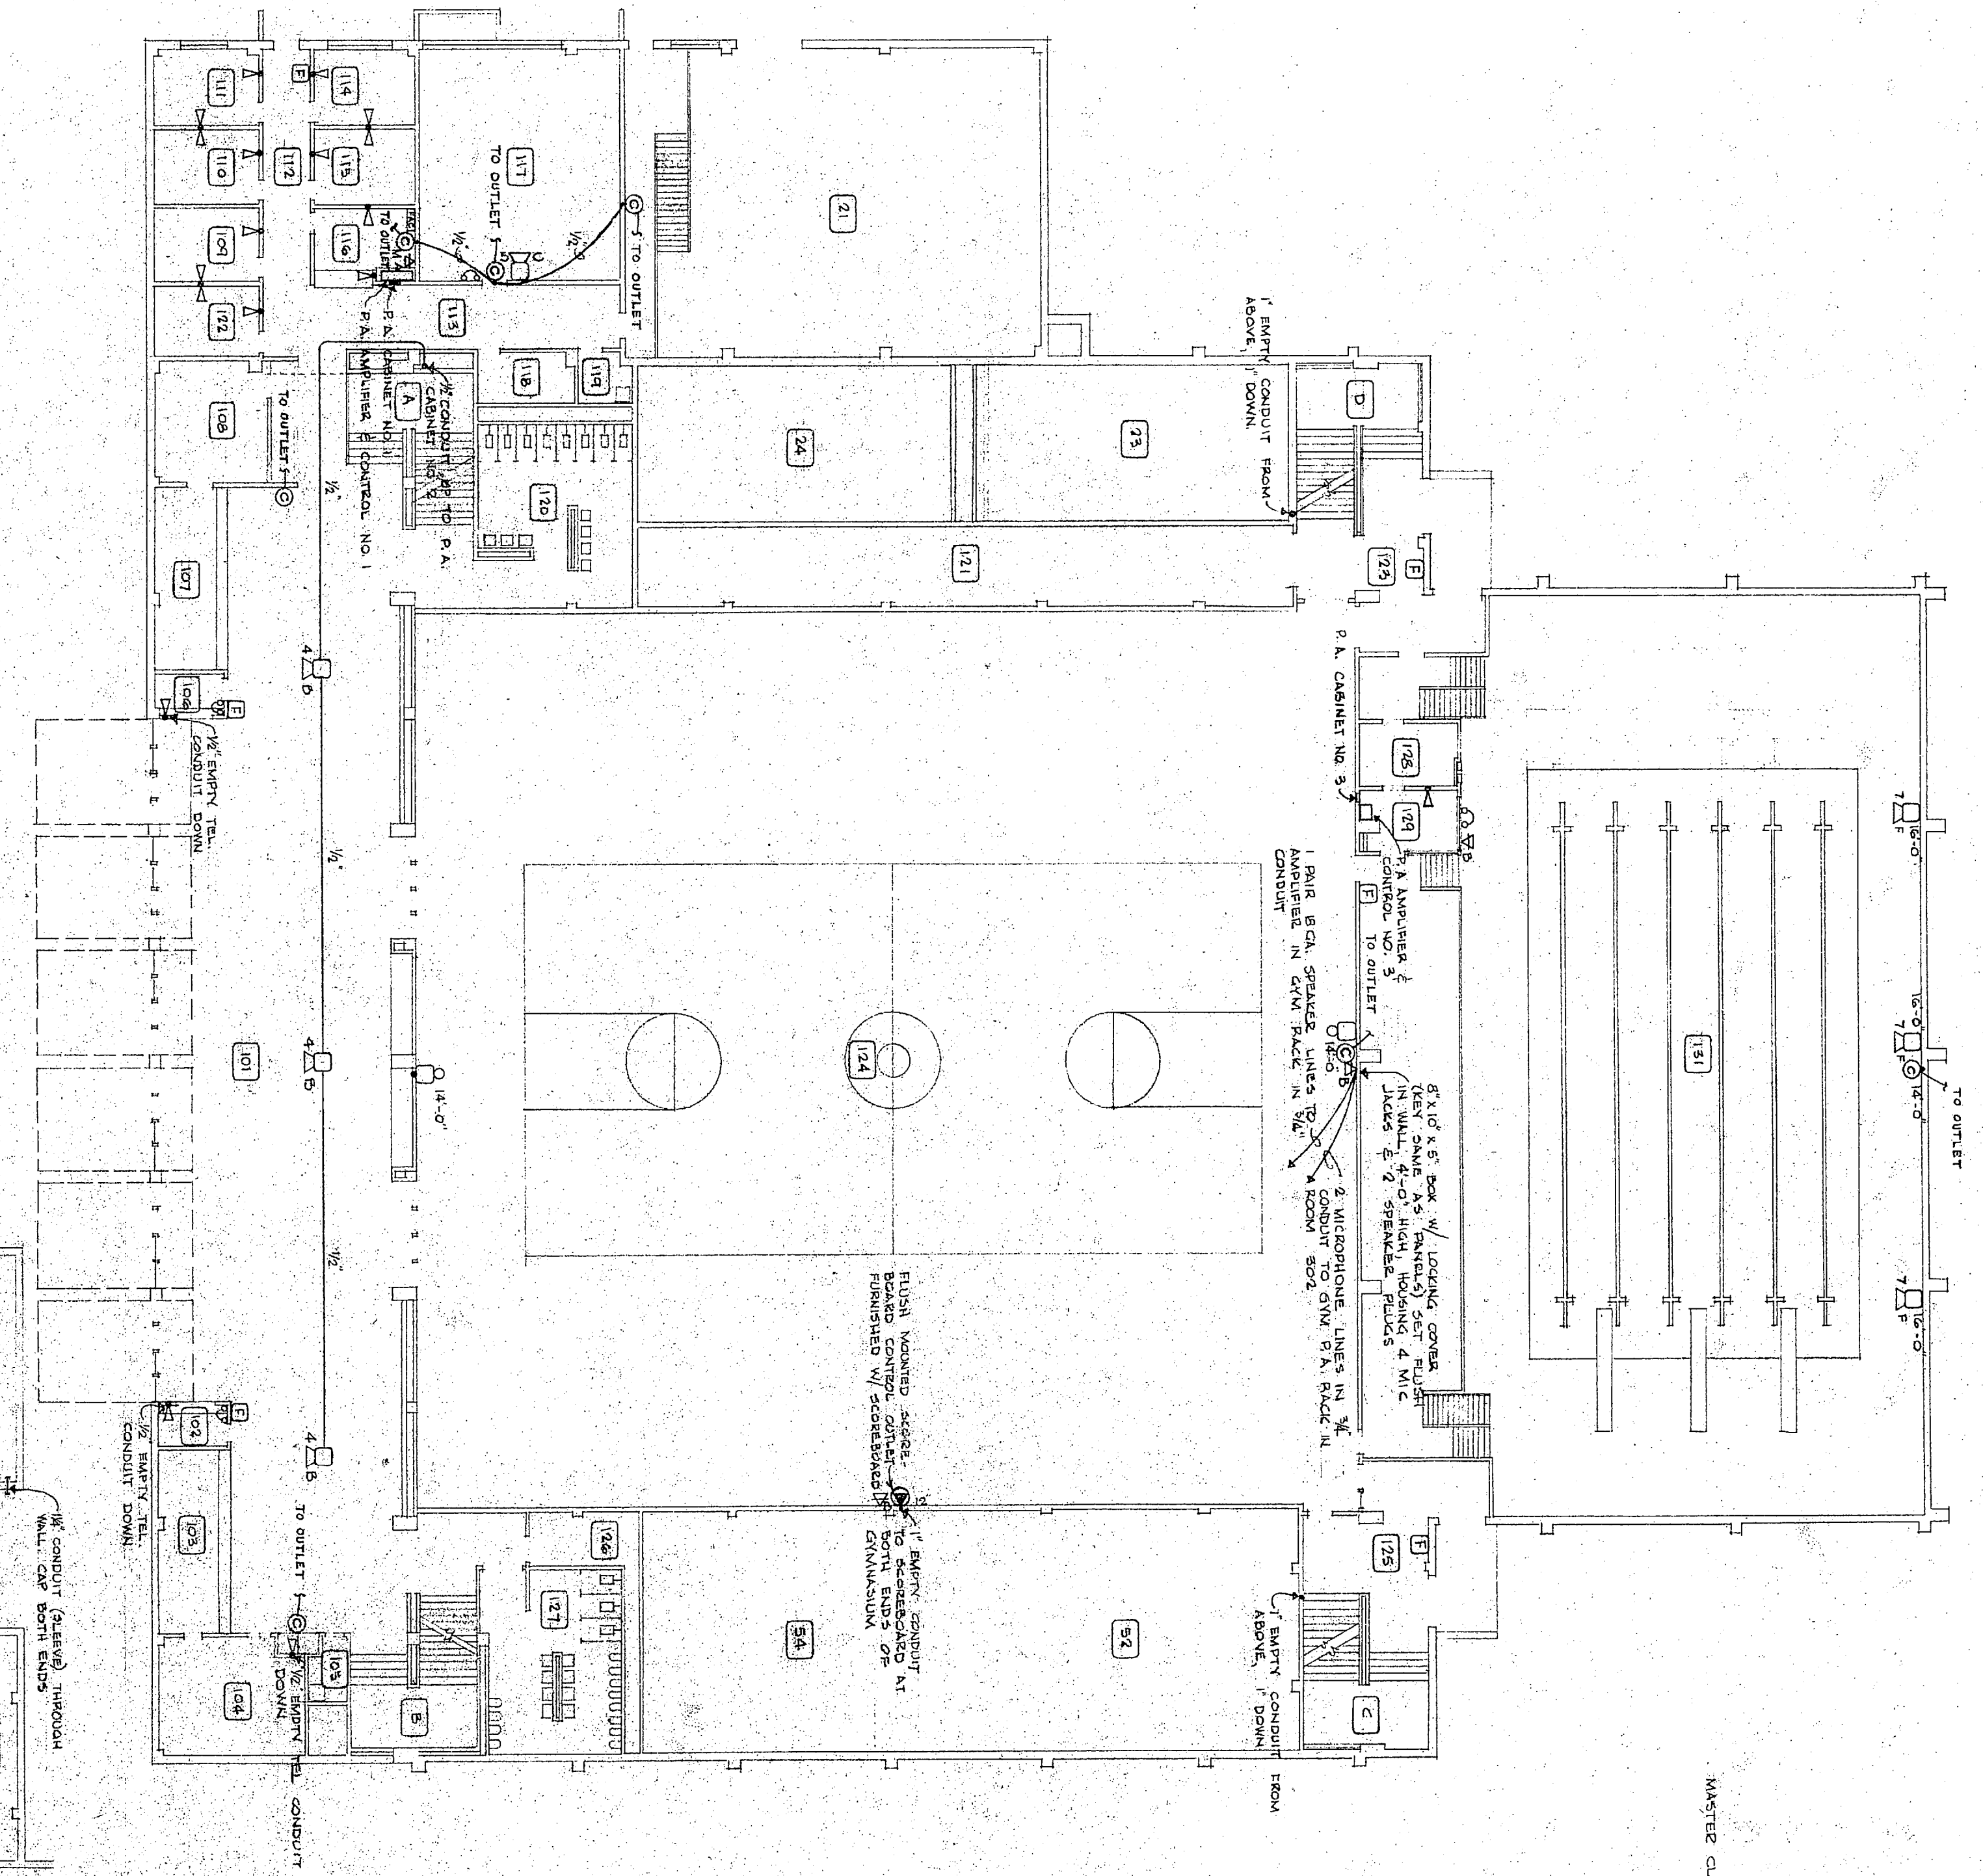


SECOND & THIRD FLOOR PLANS SCALE 1/8" = 1'-0"

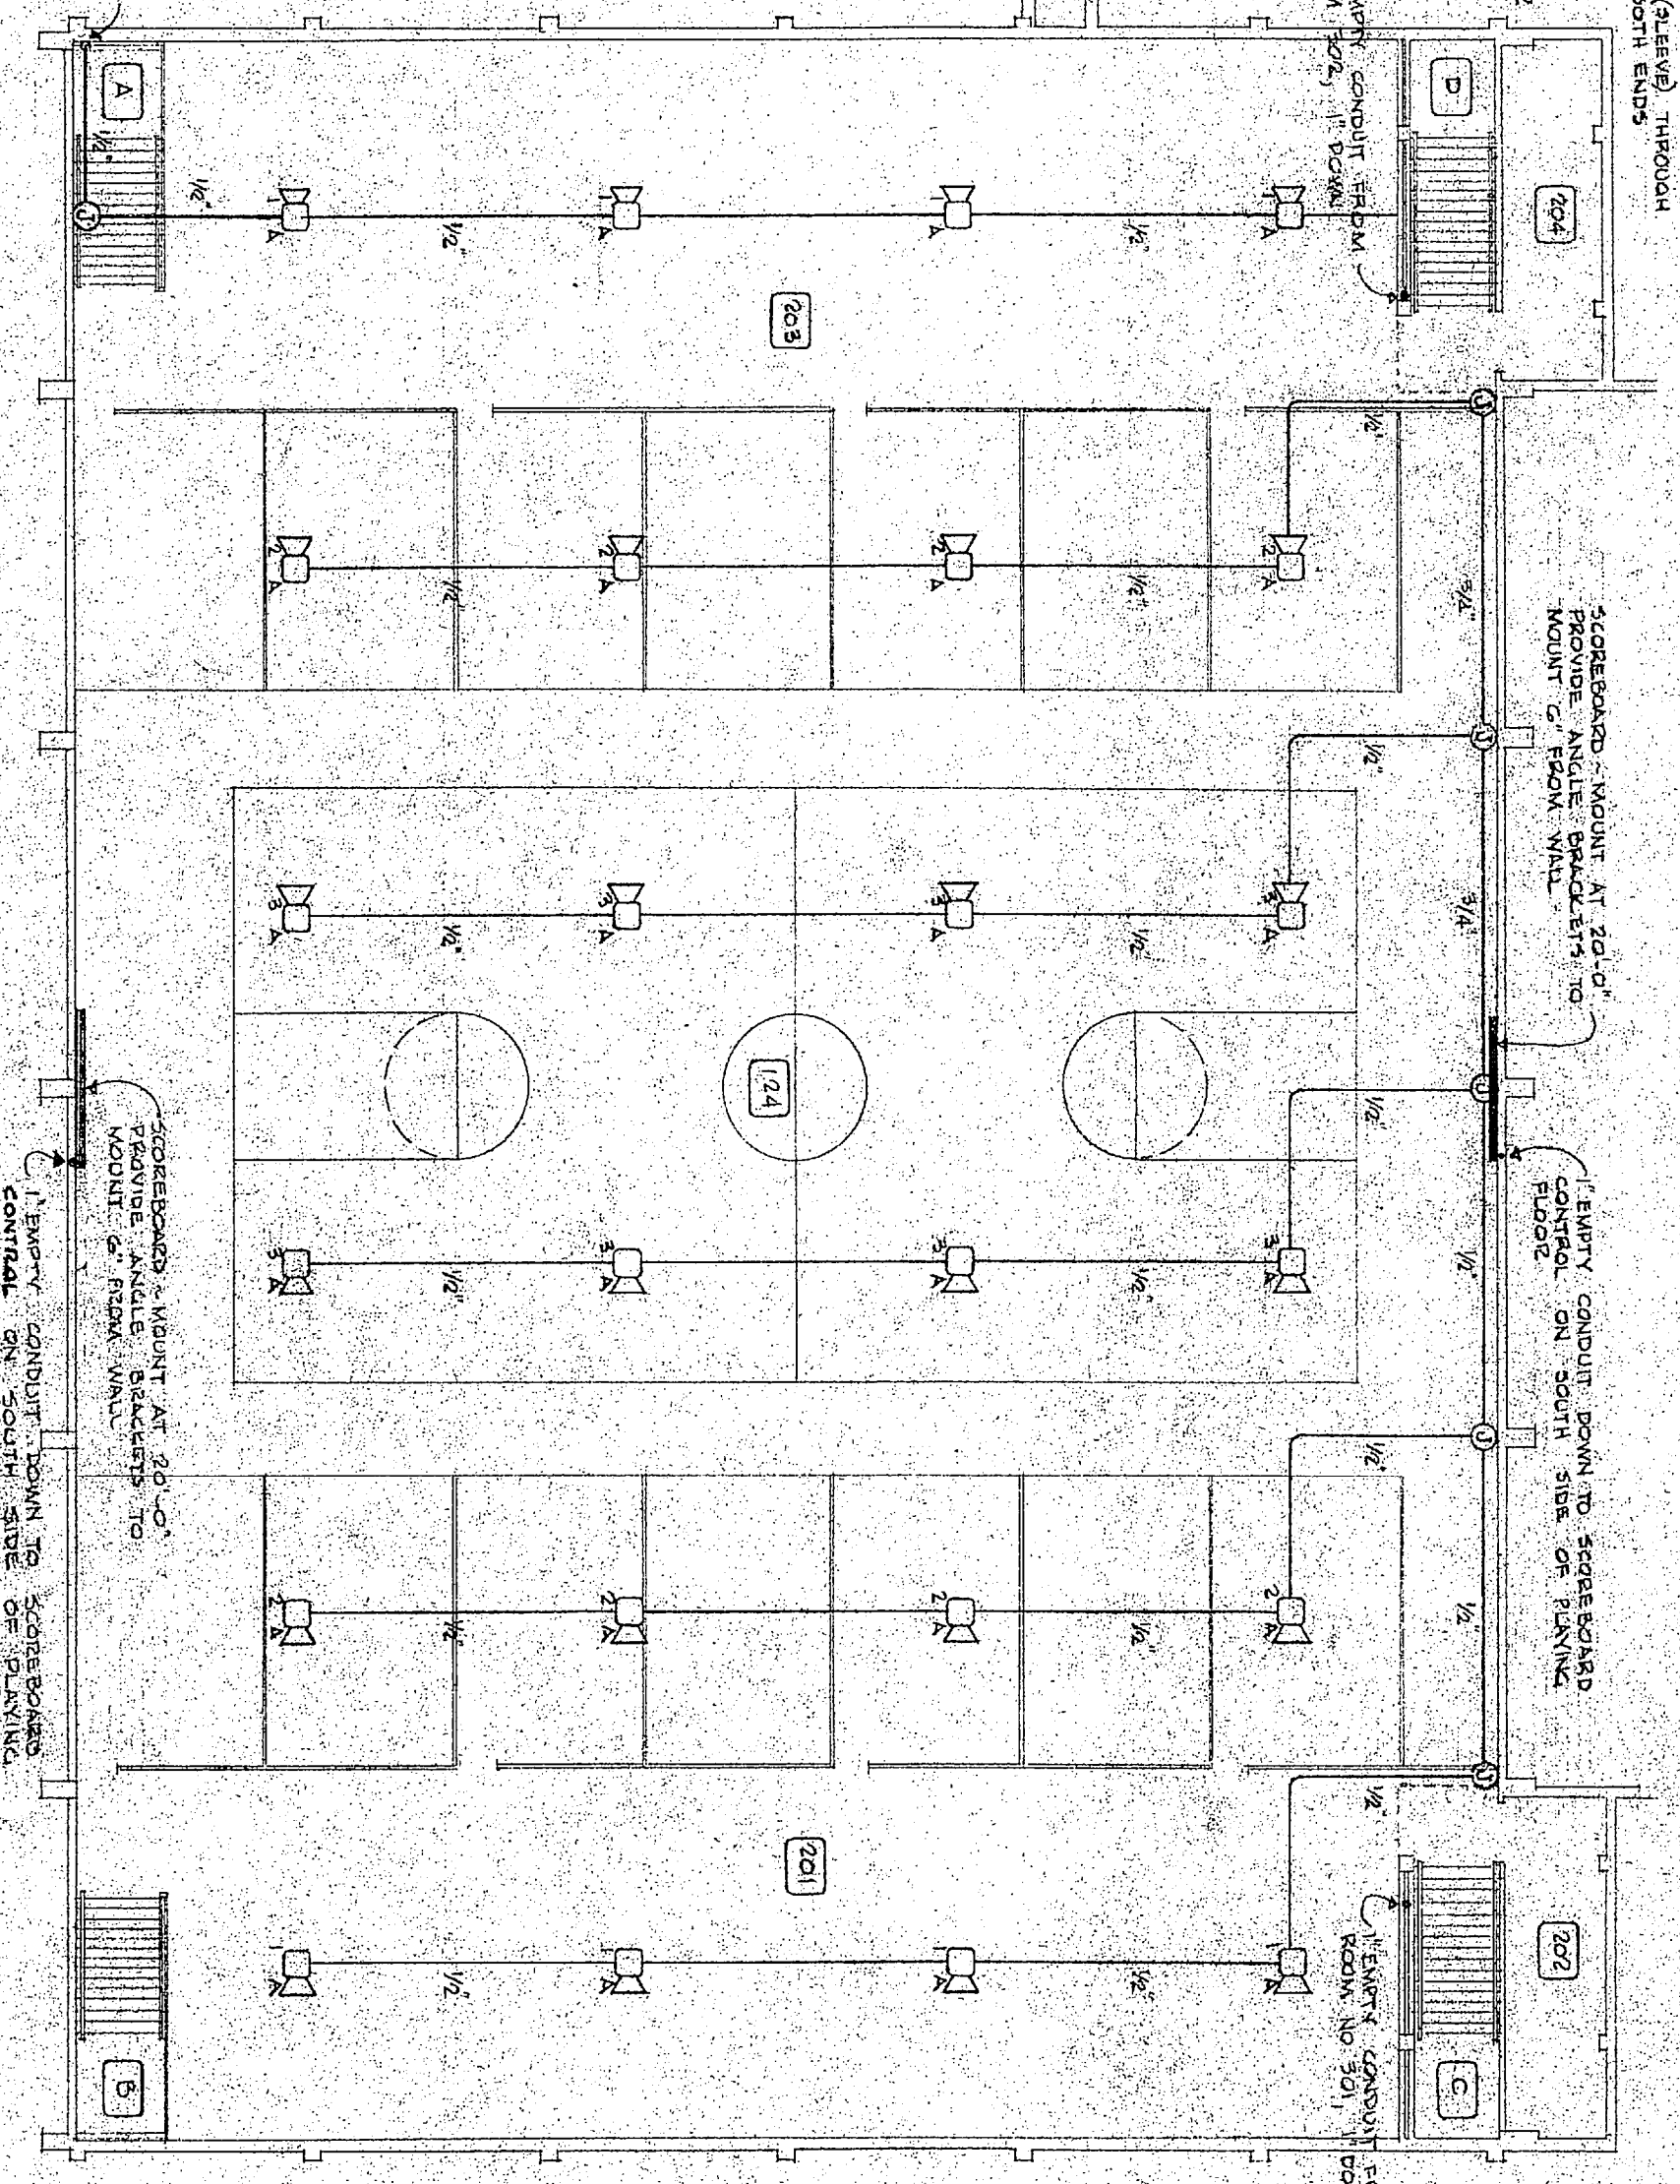


GROUND FLOOR PLAN SCALE 1/8" = 1'-0"

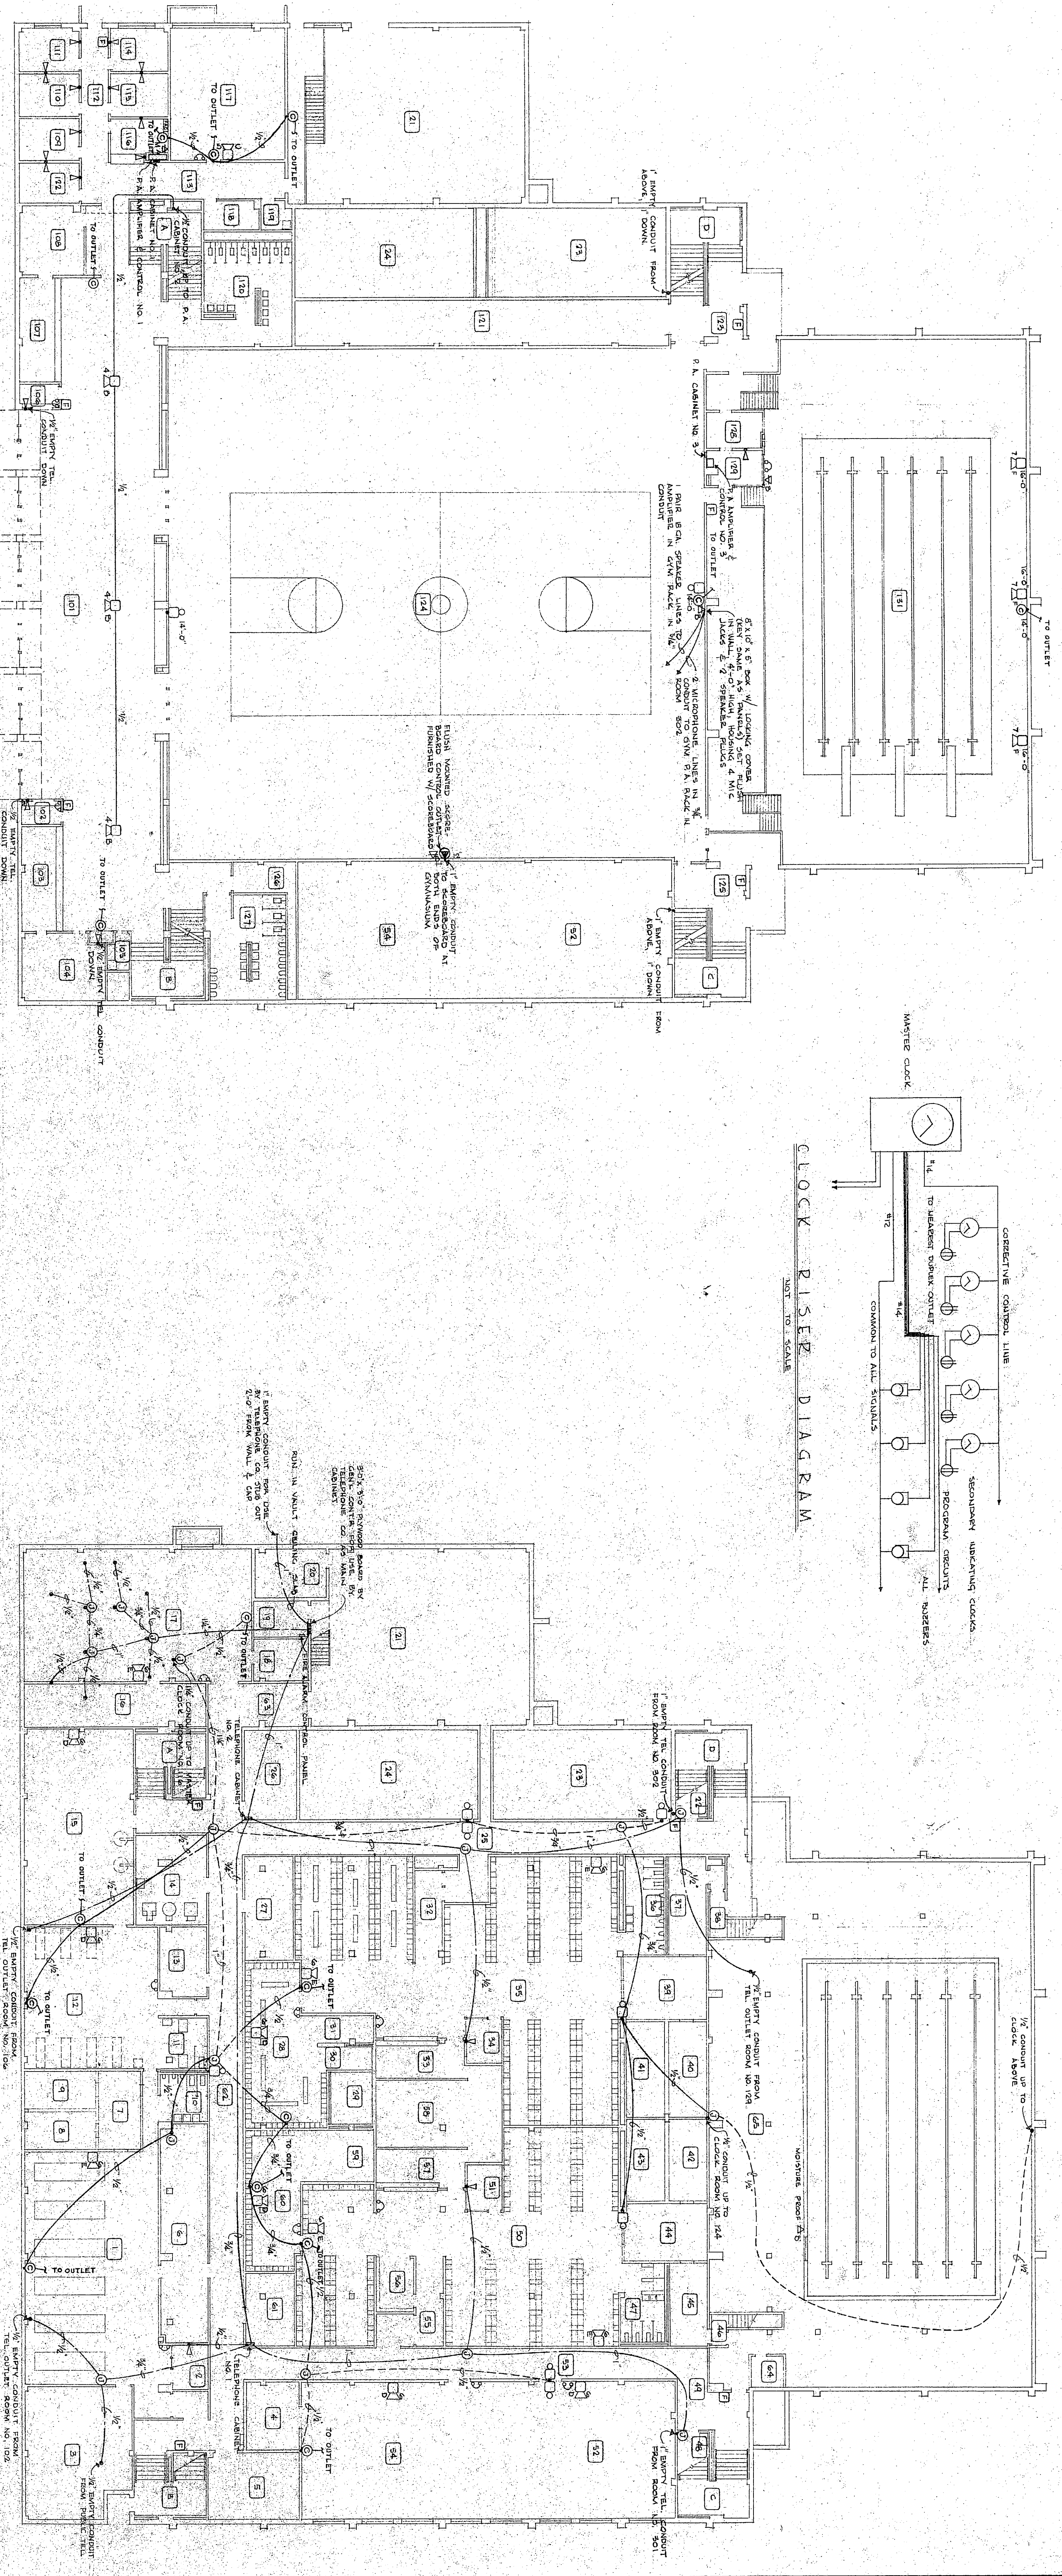

CLOCK RISER DIAGRAM NOT TO SCALE

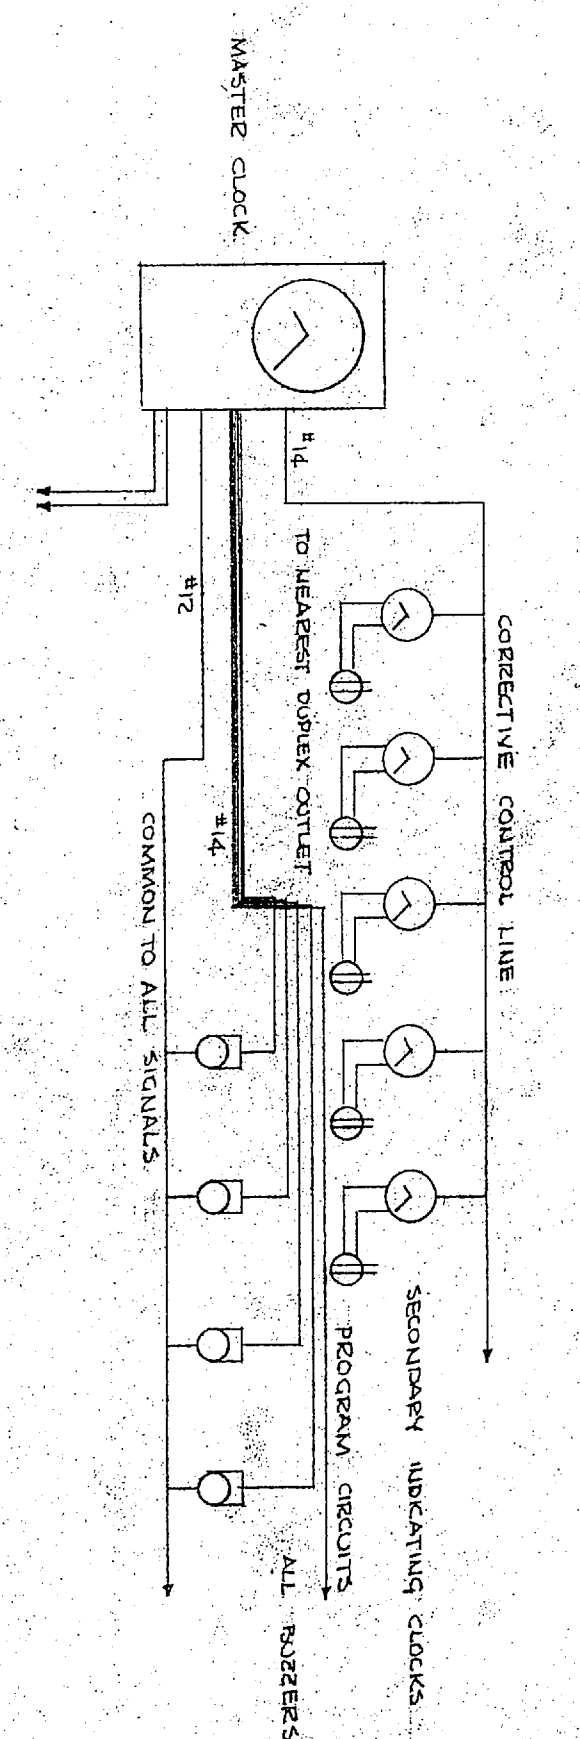

DETAIL OF SPEAKER A

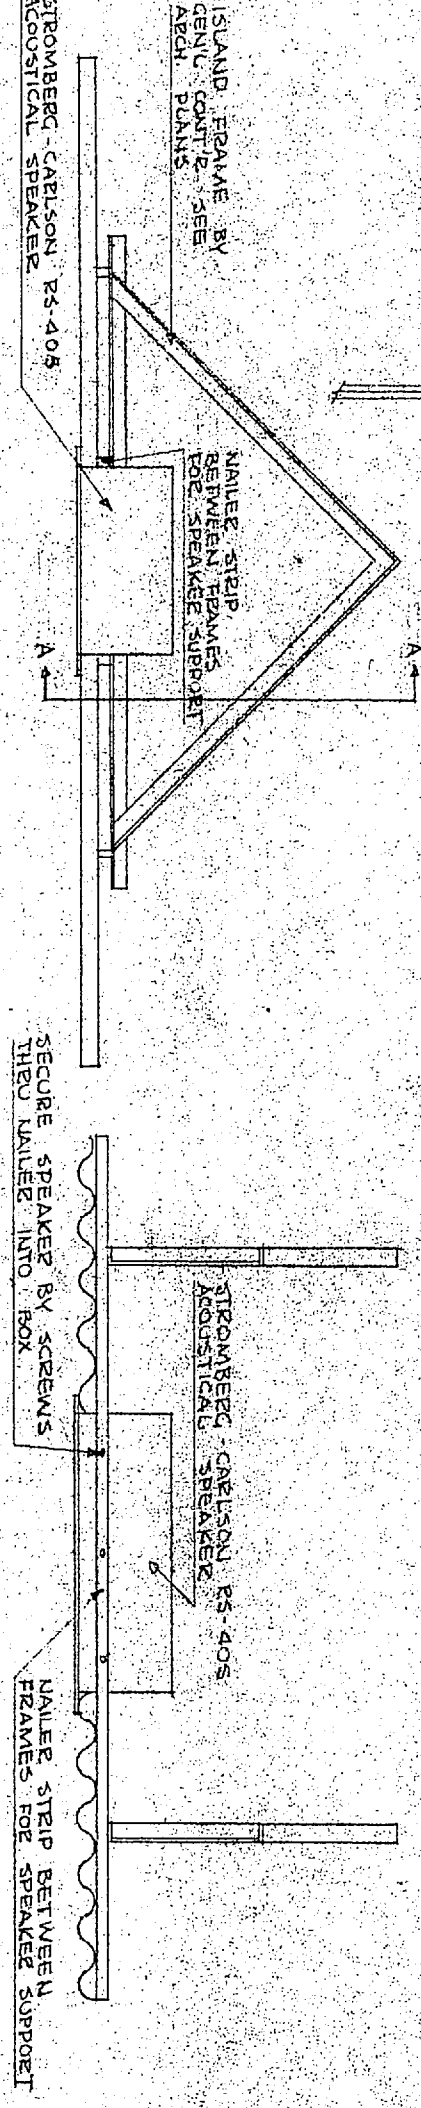

SECTION A-A

GROUND FIRST SECOND FLOOR PLANS SPECIAL SERVICES SCALE 1/8" = 1'-0"

CONSULTANTS DRAPER ENGINEERING INC. MONT.

PHYSICAL EDUCATION EASTERN MONTANA CO. BILLINGS

Associated Architects and Engineers

Checked by: [Signature] Date: 1-4-60