




THIRD FLOOR PLAN SCALE 3/8"=1'-0"

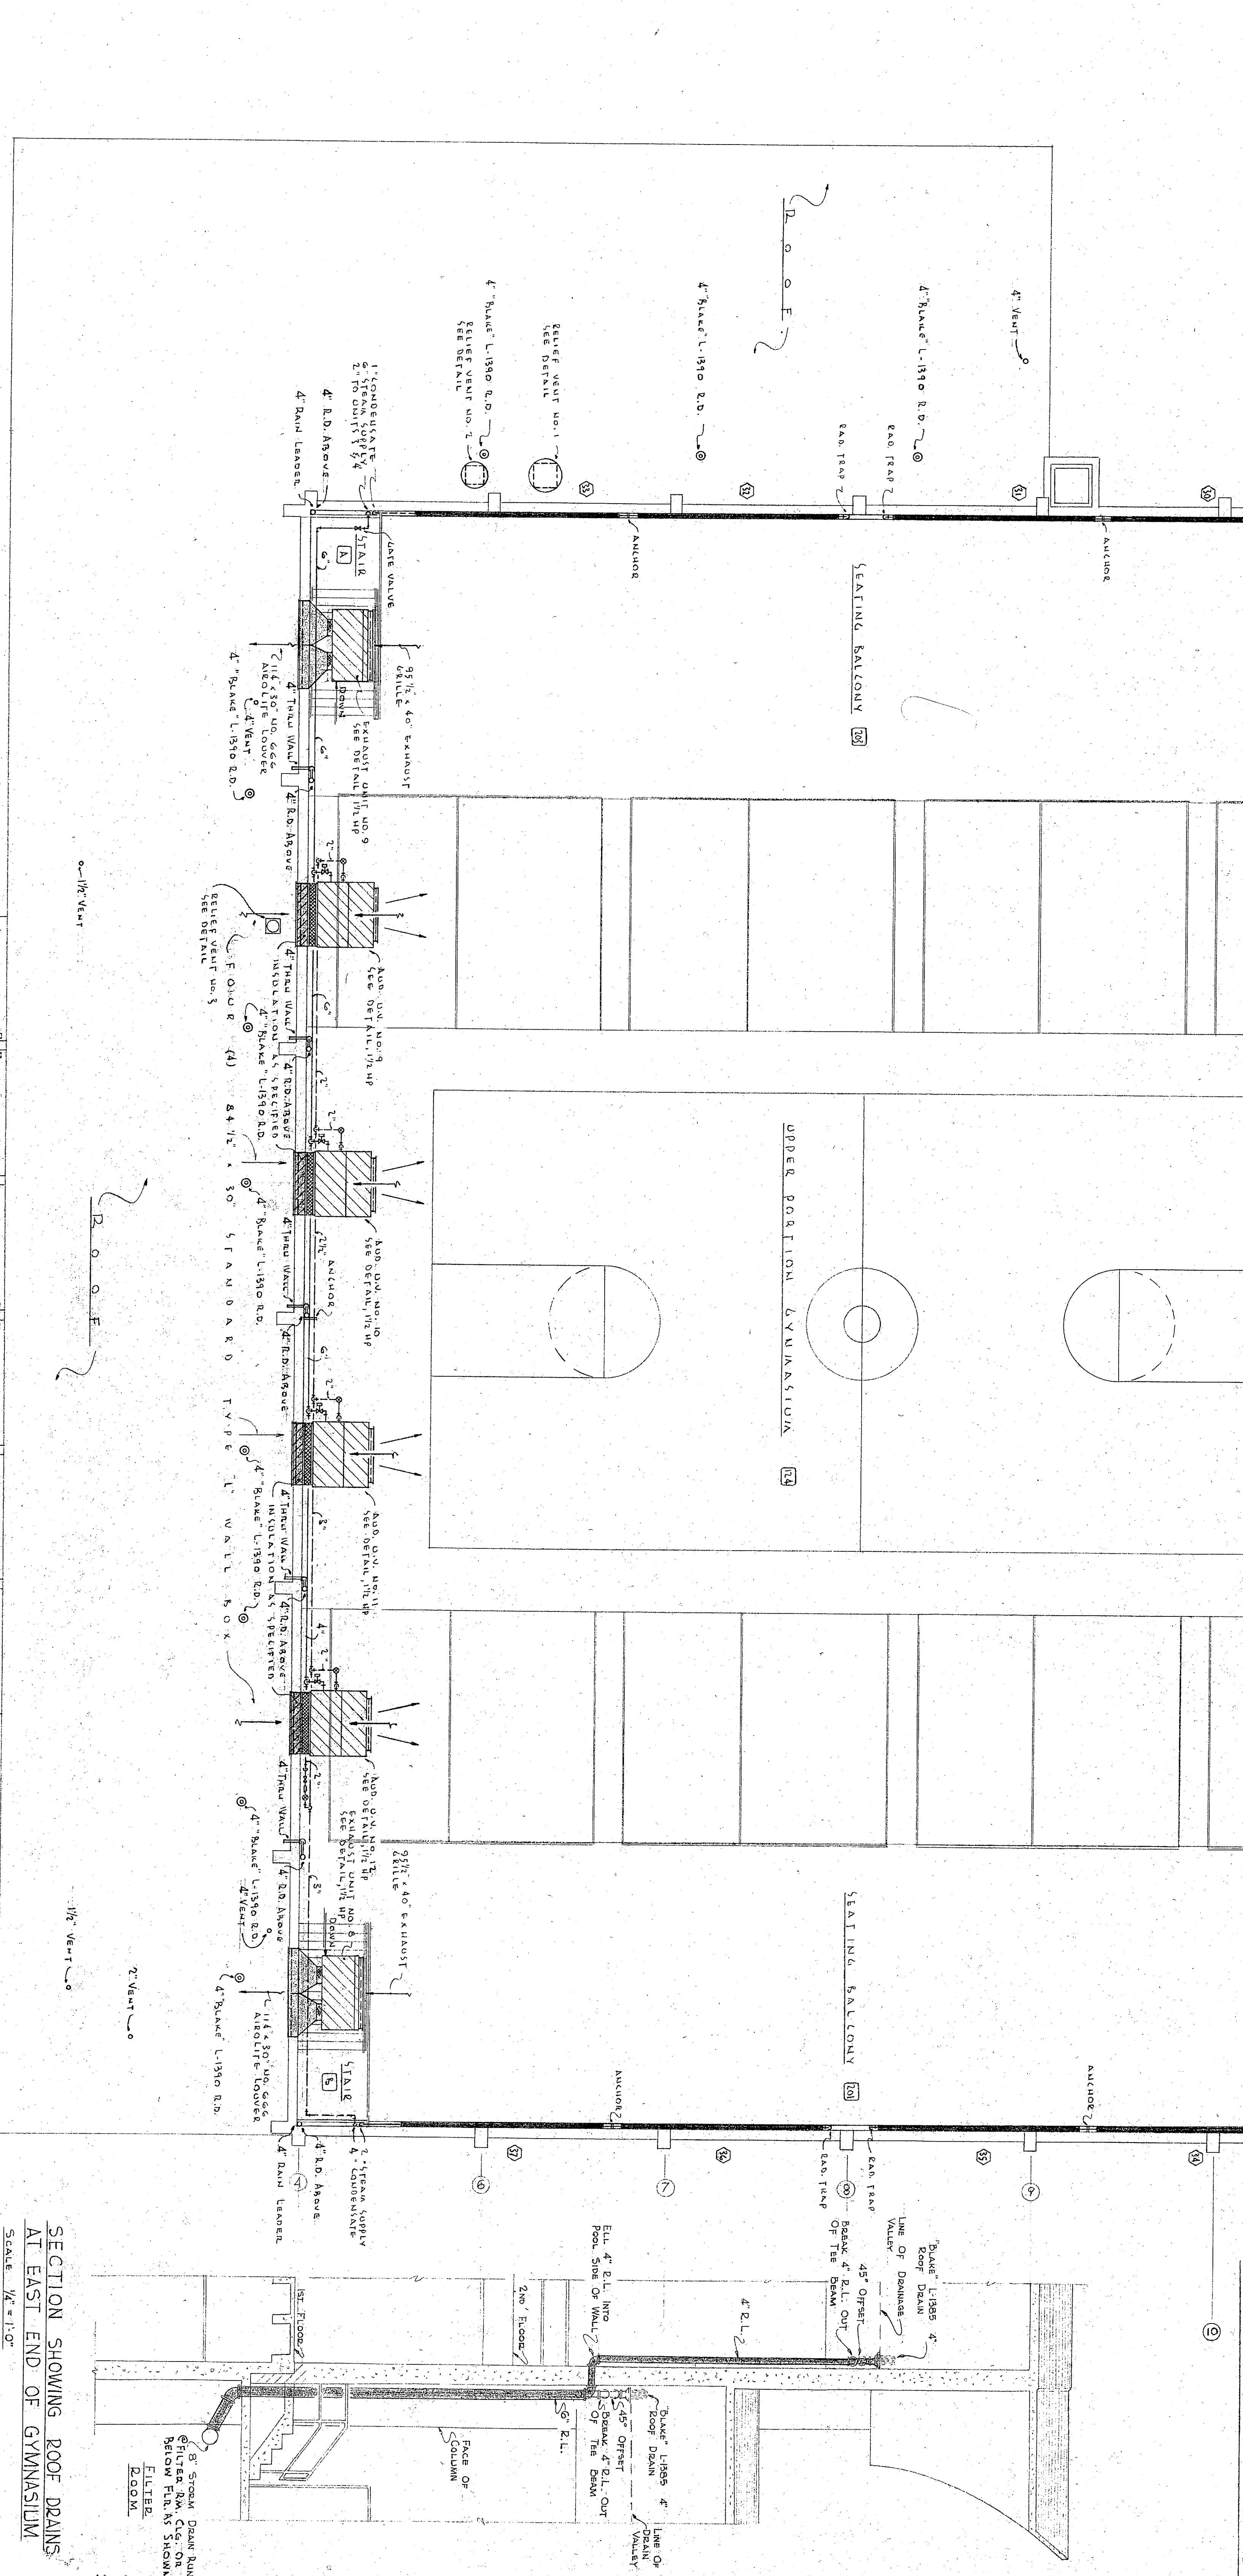

SECOND FLOOR PLAN SCALE 3/8"=1'-0"

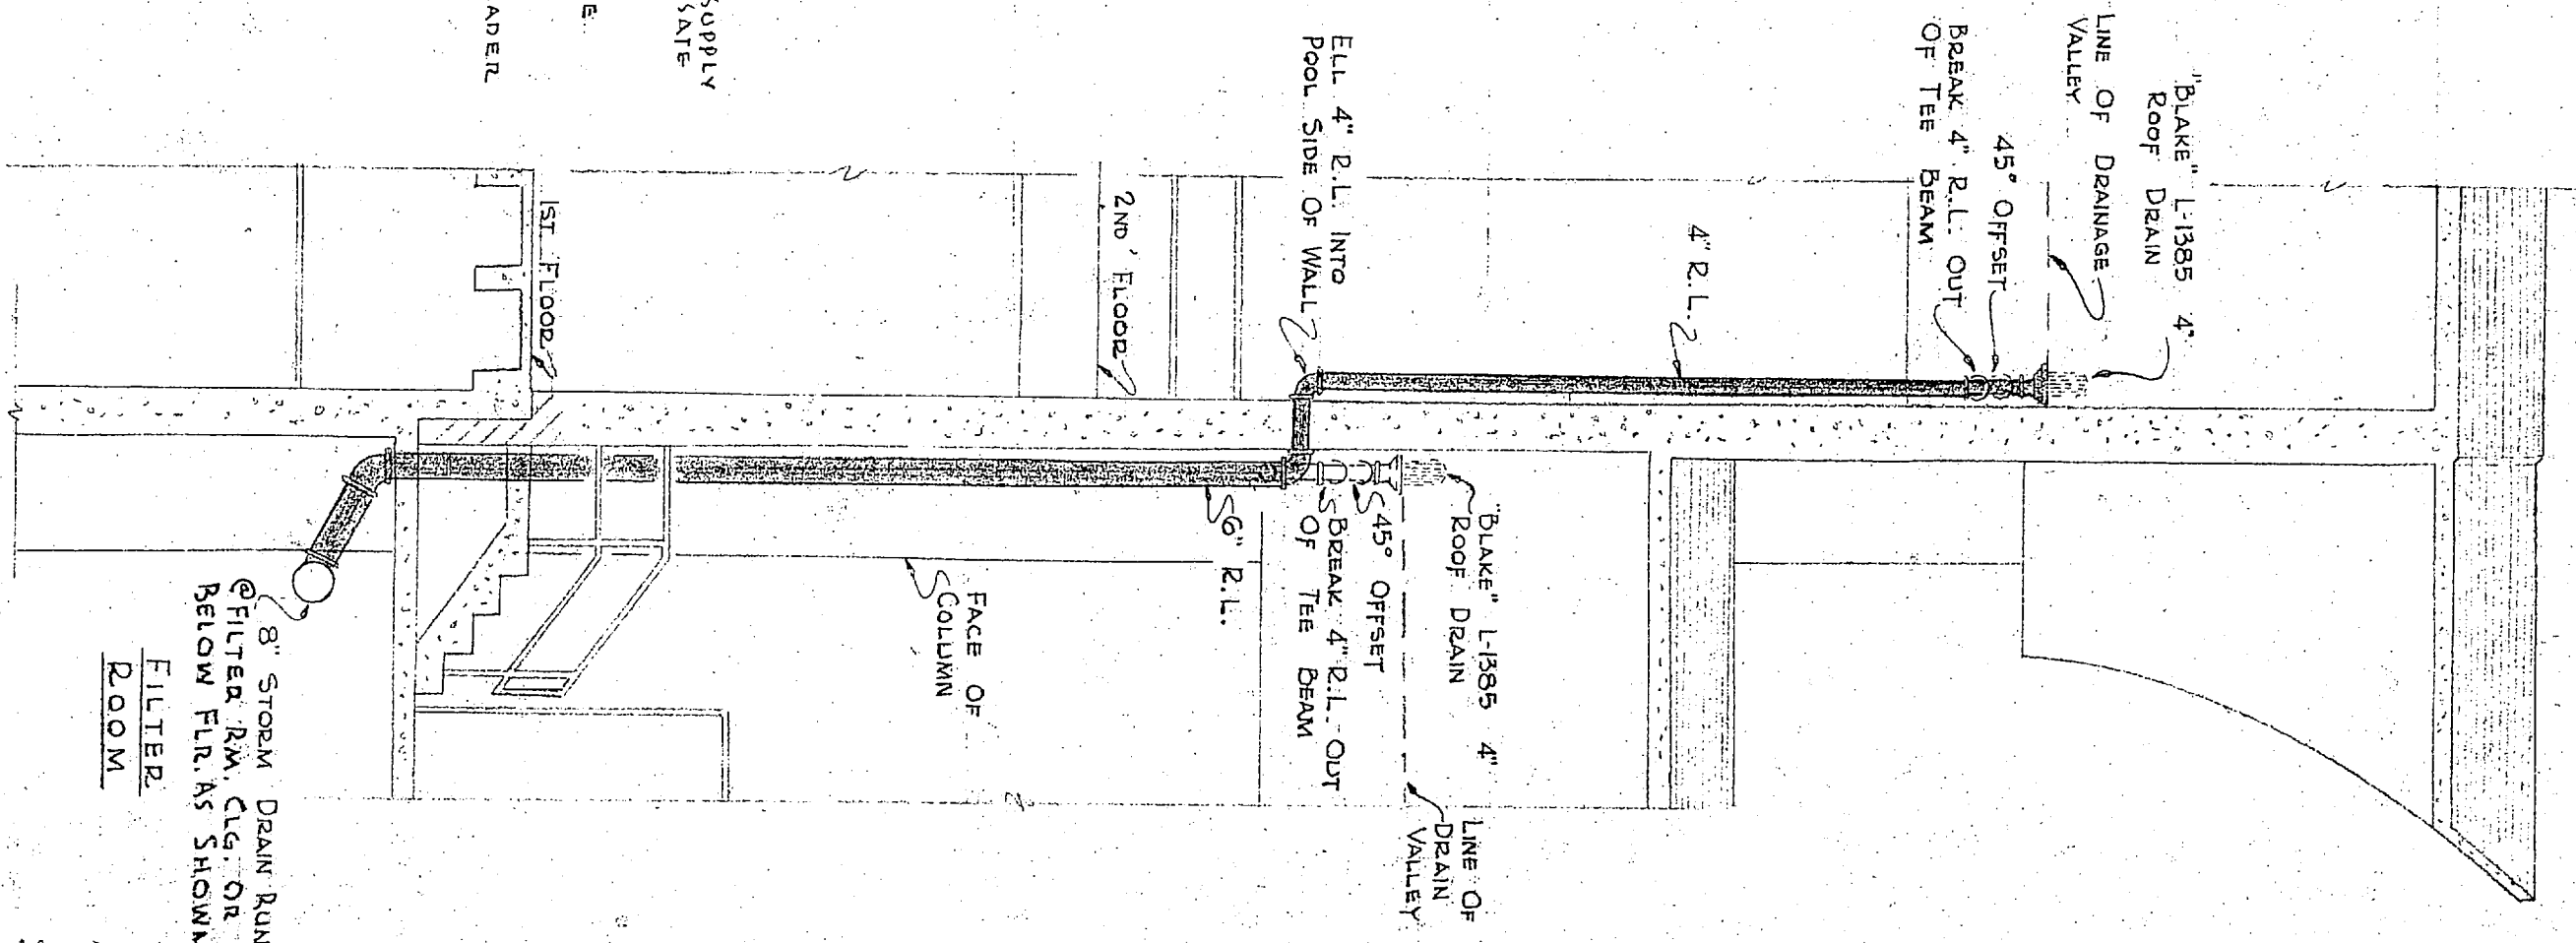

SECTION SHOWING ROOF DRAINS AT EAST END OF GYMNASIUM SCALE 1/2"=1'-0"

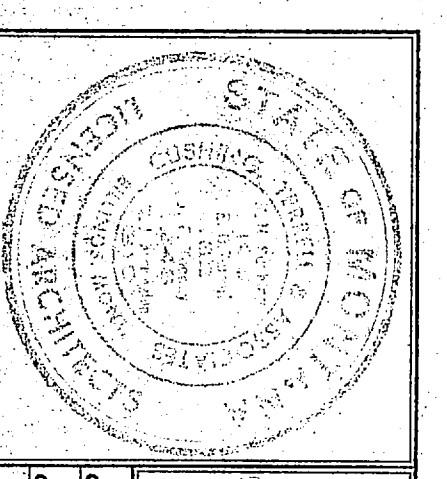

R. L. PRUSSING—MECHANICAL ENGINEER—BILLINGS, MONTANA

PHYSICAL EDUCATION BUILDING  
 EASTERN MONTANA COLLEGE OF EMERSON  
 BILLINGS

Checked: [Signature] Date: [Blank]  
 Drawn: [Signature] Date: [Blank]